

August 16, 2009

A Cut Above
1850 Bassett St. #825
Denver, CO 80202
303-332-4573

Golden Urban Renewal Authority
922 Washington Avenue Suite 100
Golden, CO 80401
303-279-4162

RE: Highway 58/Washington Ave. Bridge Decoration

Project Description:

Installation of 70 rope light snowflakes for both sides of Washington Ave on pedestrian bridges, installed with aircraft cable, from all vertical support columns on bridge. Snowflakes will be allowed to spin freely, but not allowed to swing, as they will be secured on the top and bottom of snowflake.

Project Pricing: (4 options)

Option A: 24" and 36" Snowflakes (requires 80 amps)

24" Snowflakes	34 @ \$27	\$918
36" Snowflakes	36 @ \$42	\$1512
X-Wire (1000' rolls) (Green)	1 @ \$100	\$100
X-Wire male end	40 @ \$.65	\$26
X-Wire female end	100 @ \$.65	\$65
Mounting hardware (ESTIMATE ONLY)	1 @ \$750	\$750
Initial fabrication labor	1 @ \$600	\$600
Installation/Removal labor	1 @ \$3200	\$3200
	Total	\$7171


Option B: 24" and 36" Snowflakes (FADING) (requires 80 amps)

24" Snowflakes	34 @ \$27	\$918
36" Snowflakes	36 @ \$42	\$1512
4 channel fader	12 @ \$115	\$1380
X-Wire (1000' rolls) (Green)	2 @ \$100	\$200
X-Wire male end	80 @ \$.65	\$52
X-Wire female end	100 @ \$.65	\$65
Mounting hardware (ESTIMATE ONLY)	1 @ \$750	\$750
Initial fabrication labor	1 @ \$1500	\$1500
Installation/Removal labor	1 @ \$3600	\$3600
	Total	\$9977

FOR BURIED UTILITY INFORMATION
TWO (2) BUSINESS DAYS
BEFORE YOU DIG
CALL 1-800-922-1987
UTILITY NOTIFICATION
CENTER OF COLORADO (UNCC)

WORK NOTES

- ◇ 3/4" PVC CONDUIT IN 24" DEEP TRENCH TO 14'-0" DEEP. REFER TO BRIDGE LIGHTING PLAN SHEET LEGS FOR LOCATION.
- ◇ TO 400V JUNCTION BOX, TRANSITION TO GRC AT STRUCTURE. REFER TO ONE-LINE CONNECTION DIAGRAM (LEA).

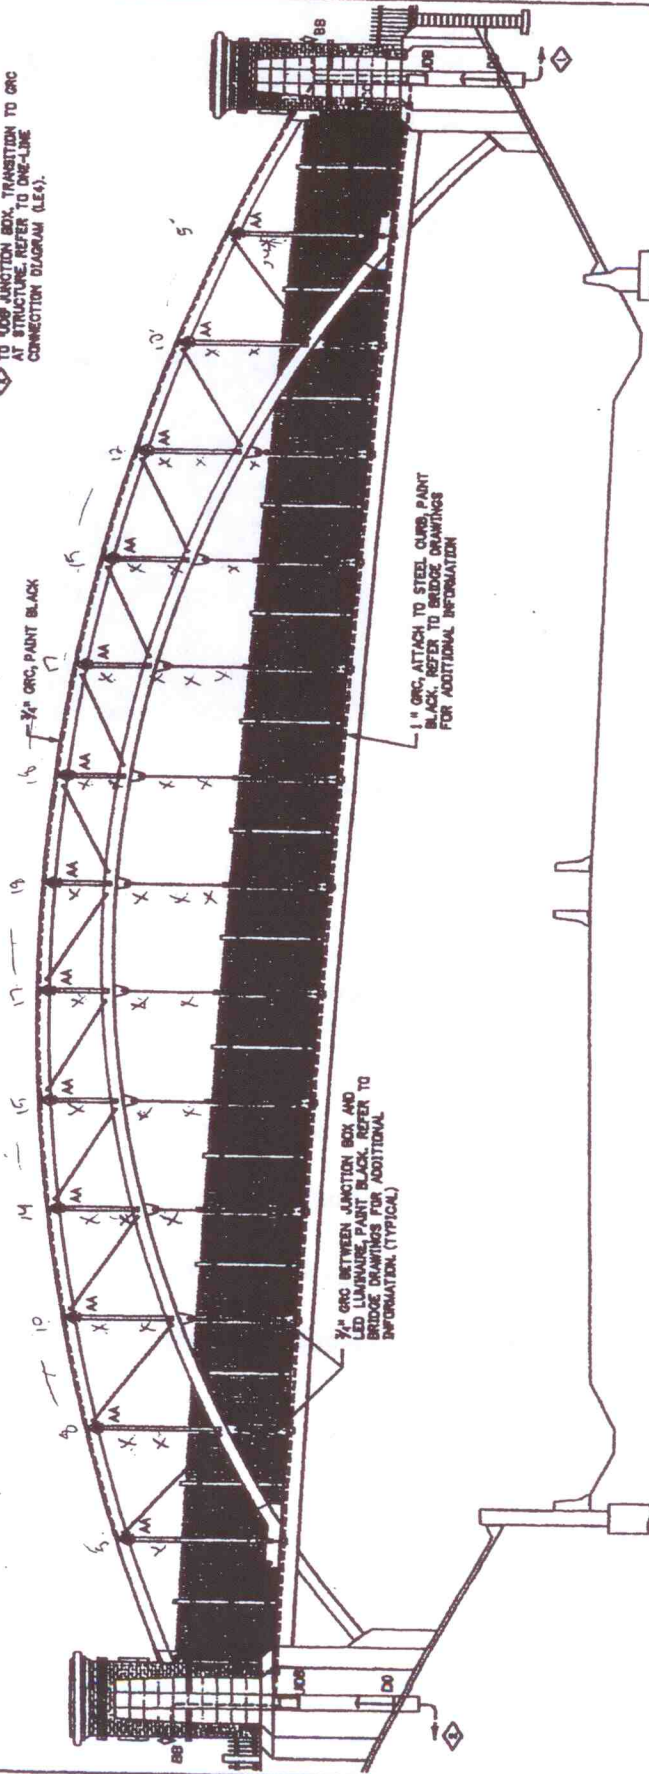

BRIDGE LIGHTING SECTION - EAST
Scale 1/4"=10'-0"

Print Date: 10/30/2007	File Name: J16578L Lighting.dgn	Ver. Code: As Noted	Project No./Code: BR 0801-008
Sheet Revisions	Date	Comments	Design: GA
1			Detail: JE
2			Sheet Number: 16578
3			Sheet Number: 16578
4			Sheet Number: 16578
100			Sheet Number: 16578

Colorado Department of Transportation
Public Works Department
3445 14th Street
Denver, CO 80202
781-333-3333

City of Golden
Public Works Department
3445 14th Street
Denver, CO 80202
781-333-3333

Region 6
W/AI

Region 6
W/AI