


- GENERAL NOTES:**
- CONNECT ALL EXIT AND EM LIGHTS TO CIRCUITS SHOWN AHEAD OF LOCAL SWITCHING.
 - LUMINAIRES DENOTED "NL" SHALL BE CONNECTED AHEAD OF LOCAL SWITCHING.
 - REFER TO ARCHITECTURAL REFLECTED CEILING PLAN FOR EXACT LIGHTING FIXTURE LOCATIONS.
 - REFER TO MECHANICAL PLANS FOR EXACT LOCATIONS OF ALL MECHANICAL EQUIPMENT.
 - ALL CONDUCTORS SHALL BE COPPER AND #12 UNLESS OTHERWISE NOTED.
 - ALL SWITCHES, CONVENIENCE RECEPTACLES, AND PLATES SHALL BE WHITE NONMETALLIC (UNLESS NOTED). CONFORM COLOR WITH ARCHITECT PRIOR TO ORDERING DEVICES.
 - LABEL ALL JUNCTION BOXES WITH CIRCUIT NUMBERING DURING ROUGH-IN OF CONDUIT SYSTEM.
 - COPIES OF ALL INSTALLATION, OPERATIONAL, AND MAINTENANCE MATERIALS ARE TO BE SAVED PROVIDED TO THE PROJECT MANAGER FOR ASSEMBLY AND DELIVERY TO THE CONTRACTOR AND OWNER.
 - THE ELECTRICAL CONTRACTOR JOB FORMAN SHALL DOCUMENT ALL UNDERGROUND FEEDERS AS WELL AS ANY DEVIATIONS TO THE CONSTRUCTION DOCUMENTS ON THE RECORD DRAWINGS. SHOW DIMENSIONS ONLY WHEN ACCURACY CAN BE ASSURED.
 - FIRE ALARM DEVICES ARE NOT SHOWN ON DRAWINGS AT THIS TIME. FIRE ALARM SHIP AND SCHEDULE SHALL BE PROVIDED BY THE ARCHITECT. FINAL LOCATIONS OF DEVICES, ONCE APPROVED BY THE A/E, WILL THEN BE TRANSFERRED TO THE ELECTRICAL CONSTRUCTION DRAWINGS.

DETAIL NOTES:

◇ SEE POLE BASE DETAIL ON SHEET S3.1

THIS SHEET ONLY

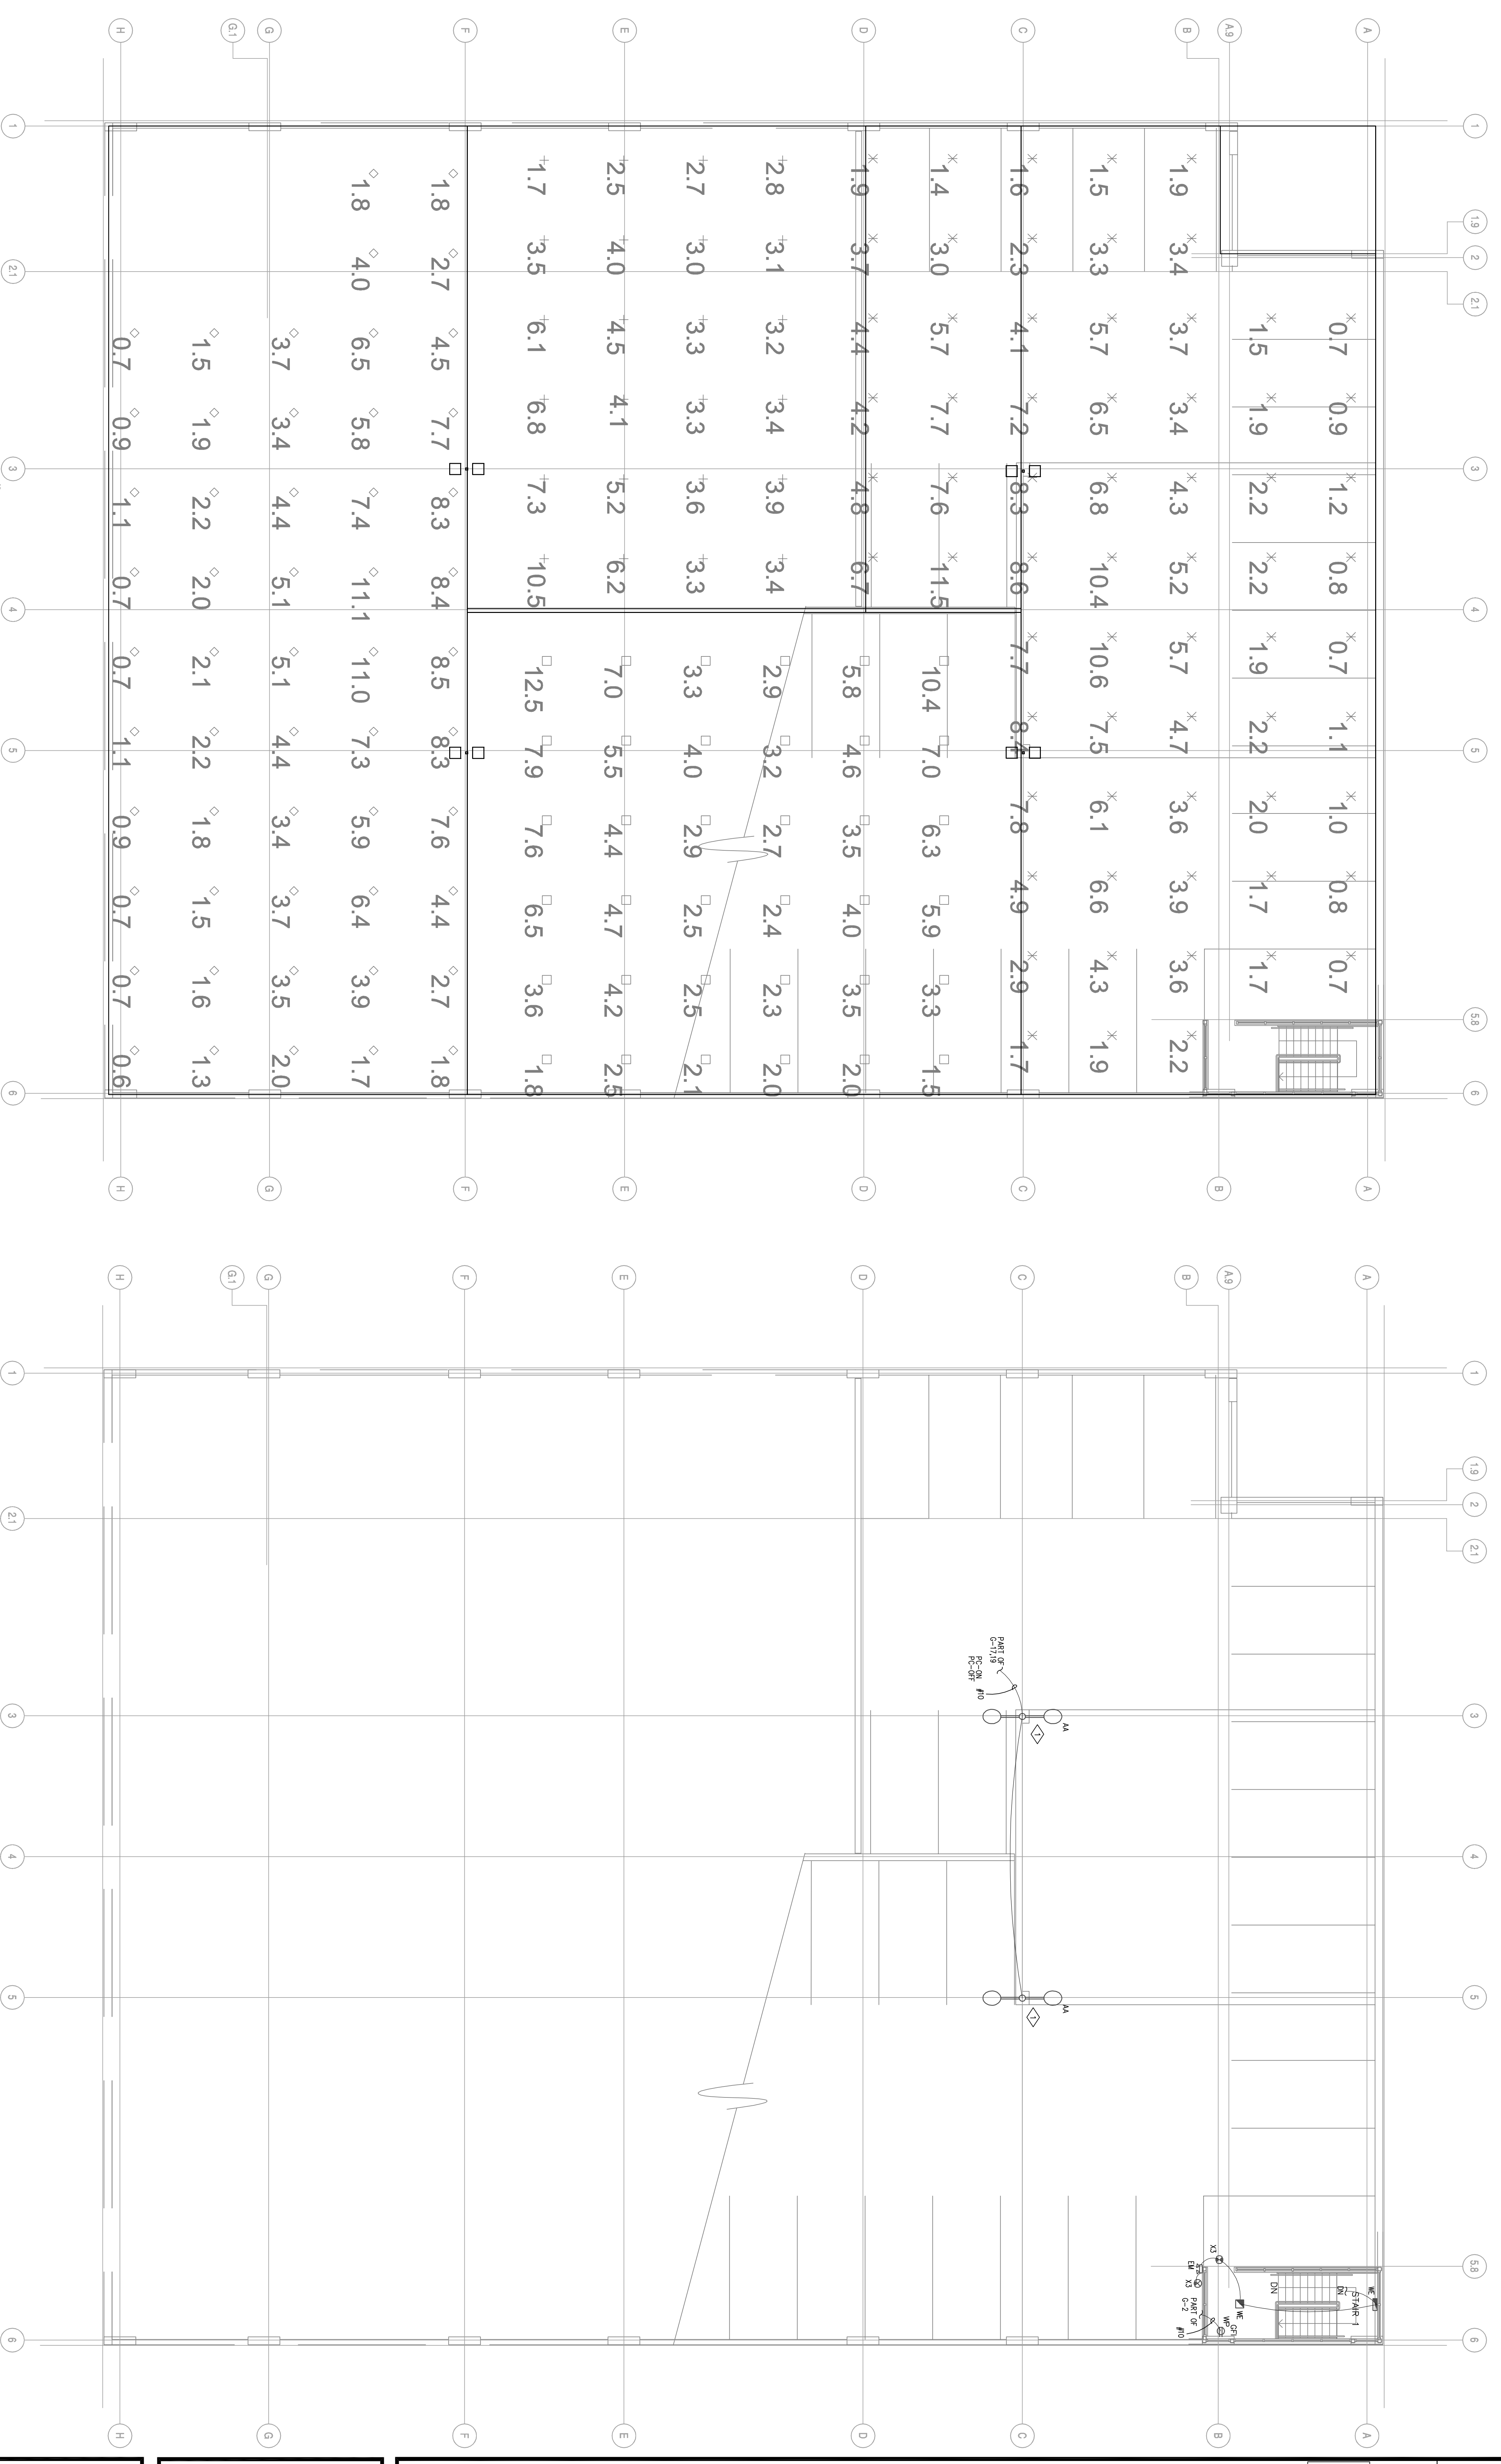

LEVEL 4 - PHOTOMETRIC PLAN
SCALE = 1/8" = 1'-0"

LEVEL 4 - POWER PLAN
SCALE = 1/8" = 1'-0"

RECORD DRAWING ACCURATE AS OF:
RECORD DRAWING PREPARED BY: BRETT'S ELECTRIC

RECORD DRAWINGS

GOLDEN GURA GARAGE
Jackson St.
Golden, Colorado

SRRB CONSULTING ENGINEERS
ARCHITECTS • ELECTRICAL • MECHANICAL

BRETT'S ELECTRIC LLC
ELECTRICAL CONTRACTORS
3004 S. W. 10TH AVE.
BOULDER, CO 80504-9419
www.bretts-electric.com

Q7 ARCHITECTURE

1820 Folsom Street
Boulder, Colorado 80302
phone 303.449.9900

NexCore GROUP

PROJ. NO. 15038.00
DRAWN: LNS/CW
CHECKED: LNS
CADD FILE: 5060 Garage-4
DATE: 1-14-08
REVISIONS:

ADD. NO. 1 8/10/08
CITY REVIEW COMMENTS 9/27/06
ADD. NO. 2 11/20/07
REV 4

© OZ ARCHITECTURE

GURA GARAGE
RECORD DRAWINGS
REVISIONS:
DATE: 1-14-08

SCALE AS NOTED
SHEET NUMBER:
E2.04