




1820 Polkorn Street  
Boulder, Colorado 80302  
phone 303.449.8900



**INMS**  
INNOVATIVE  
MECHANICAL  
SYSTEMS, INC.  
1280 CHESTNUT STREET, SUITE A  
LOUISVILLE, CO 80002-1088  
PHONE 303.449.1088  
FAX 303.449.1188

# GOLDEN GURA GARAGE

1250 Jackson St.  
Golden, Colorado

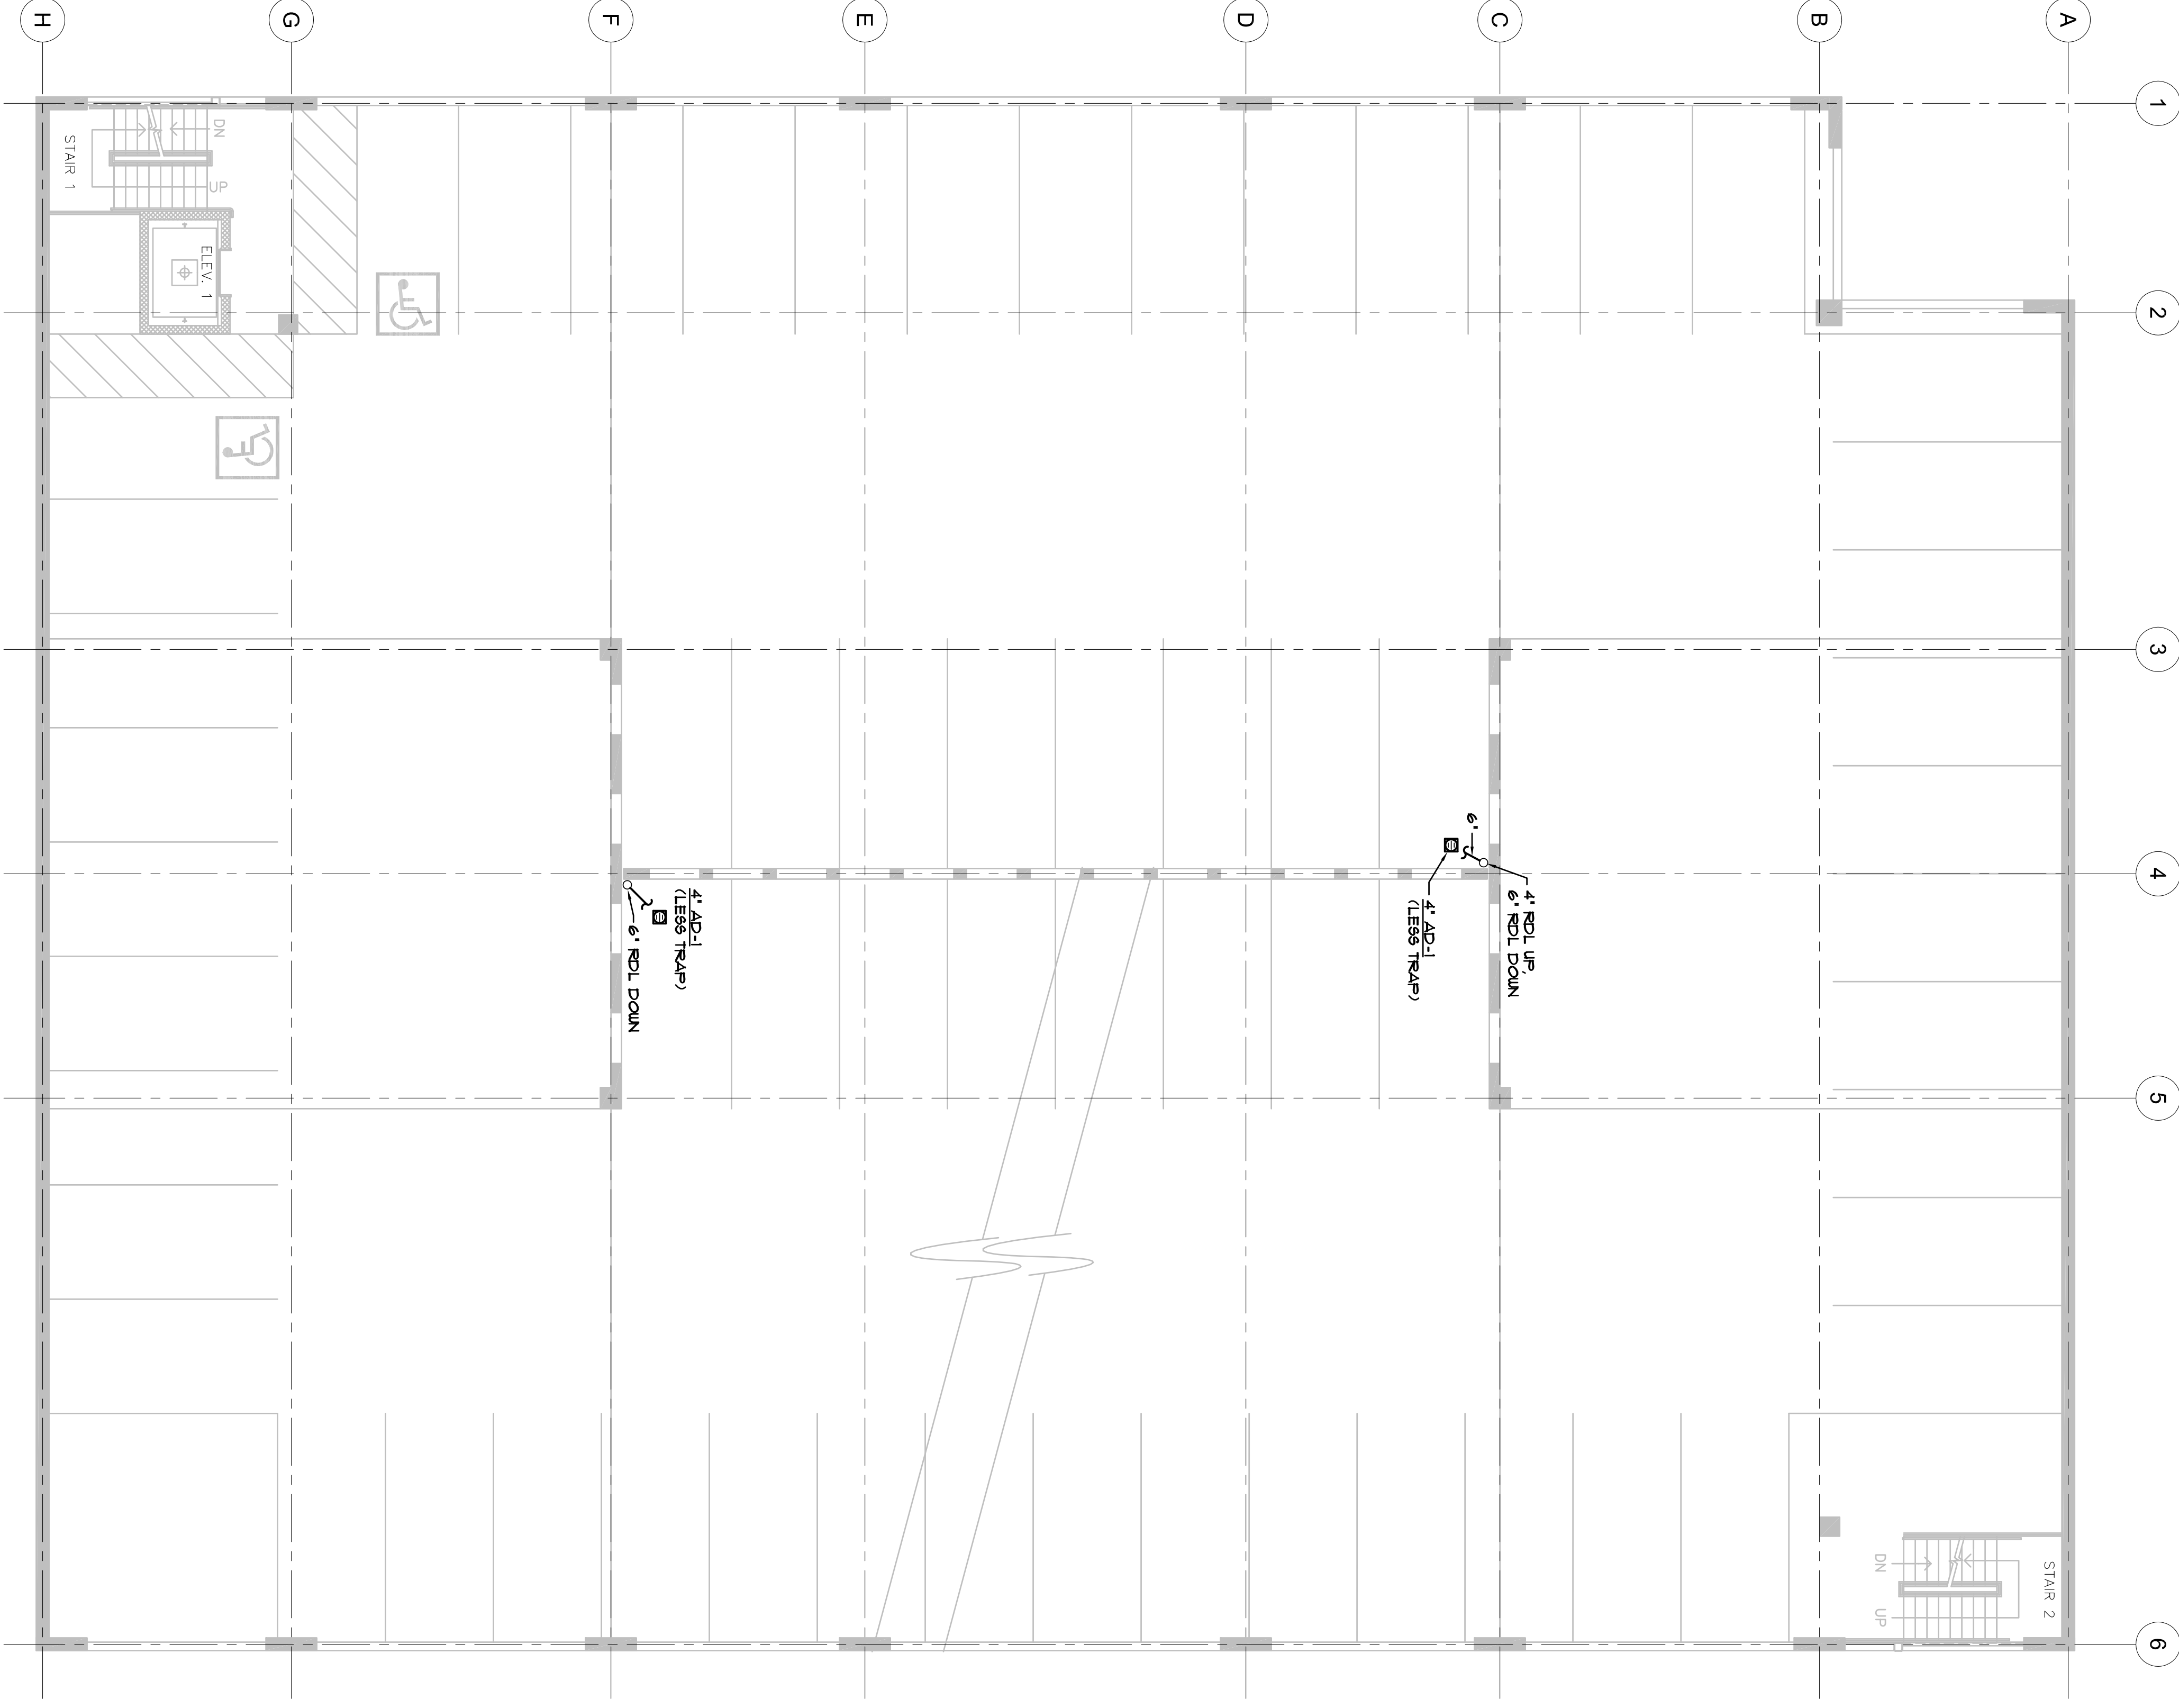

**PARKING LEVEL TWO PLUMBING PLAN**  
SCALE: 1/8" = 1'-0"  
NORTH

PROJ. NO.	15098.00
DRAWN:	TLF
CHECKED:	DER
CADD FILE:	GGM4.2.DWG
DATE:	06.16.06
REVISIONS:	07.26.06
▲ ADD. NO. 1	8.10.06
▲ ADD. NO. 2	9.27.06
RECORD DRAWING:	01.14.08
© OZ ARCHITECTURE	

GURA GARAGE  
ISSUED FOR  
CONSTRUCTION - 9/29/06

SHEET TITLE:  
PARKING  
LEVEL TWO  
PLUMBING PLAN  
SCALE: AS NOTED  
SHEET NUMBER:  
**M4.2**

THE CONTRACTOR SHALL BE RESPONSIBLE FOR OBTAINING ALL NECESSARY PERMITS AND APPROVALS FROM THE LOCAL, STATE AND FEDERAL AGENCIES. THE CONTRACTOR SHALL BE RESPONSIBLE FOR OBTAINING ALL NECESSARY PERMITS AND APPROVALS FROM THE LOCAL, STATE AND FEDERAL AGENCIES. THE CONTRACTOR SHALL BE RESPONSIBLE FOR OBTAINING ALL NECESSARY PERMITS AND APPROVALS FROM THE LOCAL, STATE AND FEDERAL AGENCIES.