




1820 Polkorn Street
Boulder, Colorado 80302
phone 303.449.8900



INMS
INNOVATIVE
MECHANICAL
SYSTEMS, INC.
1280 CHESTNUT STREET, SUITE A
BOULDER, CO 80501-3082
PHONE 303.440.0887
FAX 303.440.1188

GOLDEN GURA GARAGE

1250 Jackson St.
Golden, Colorado

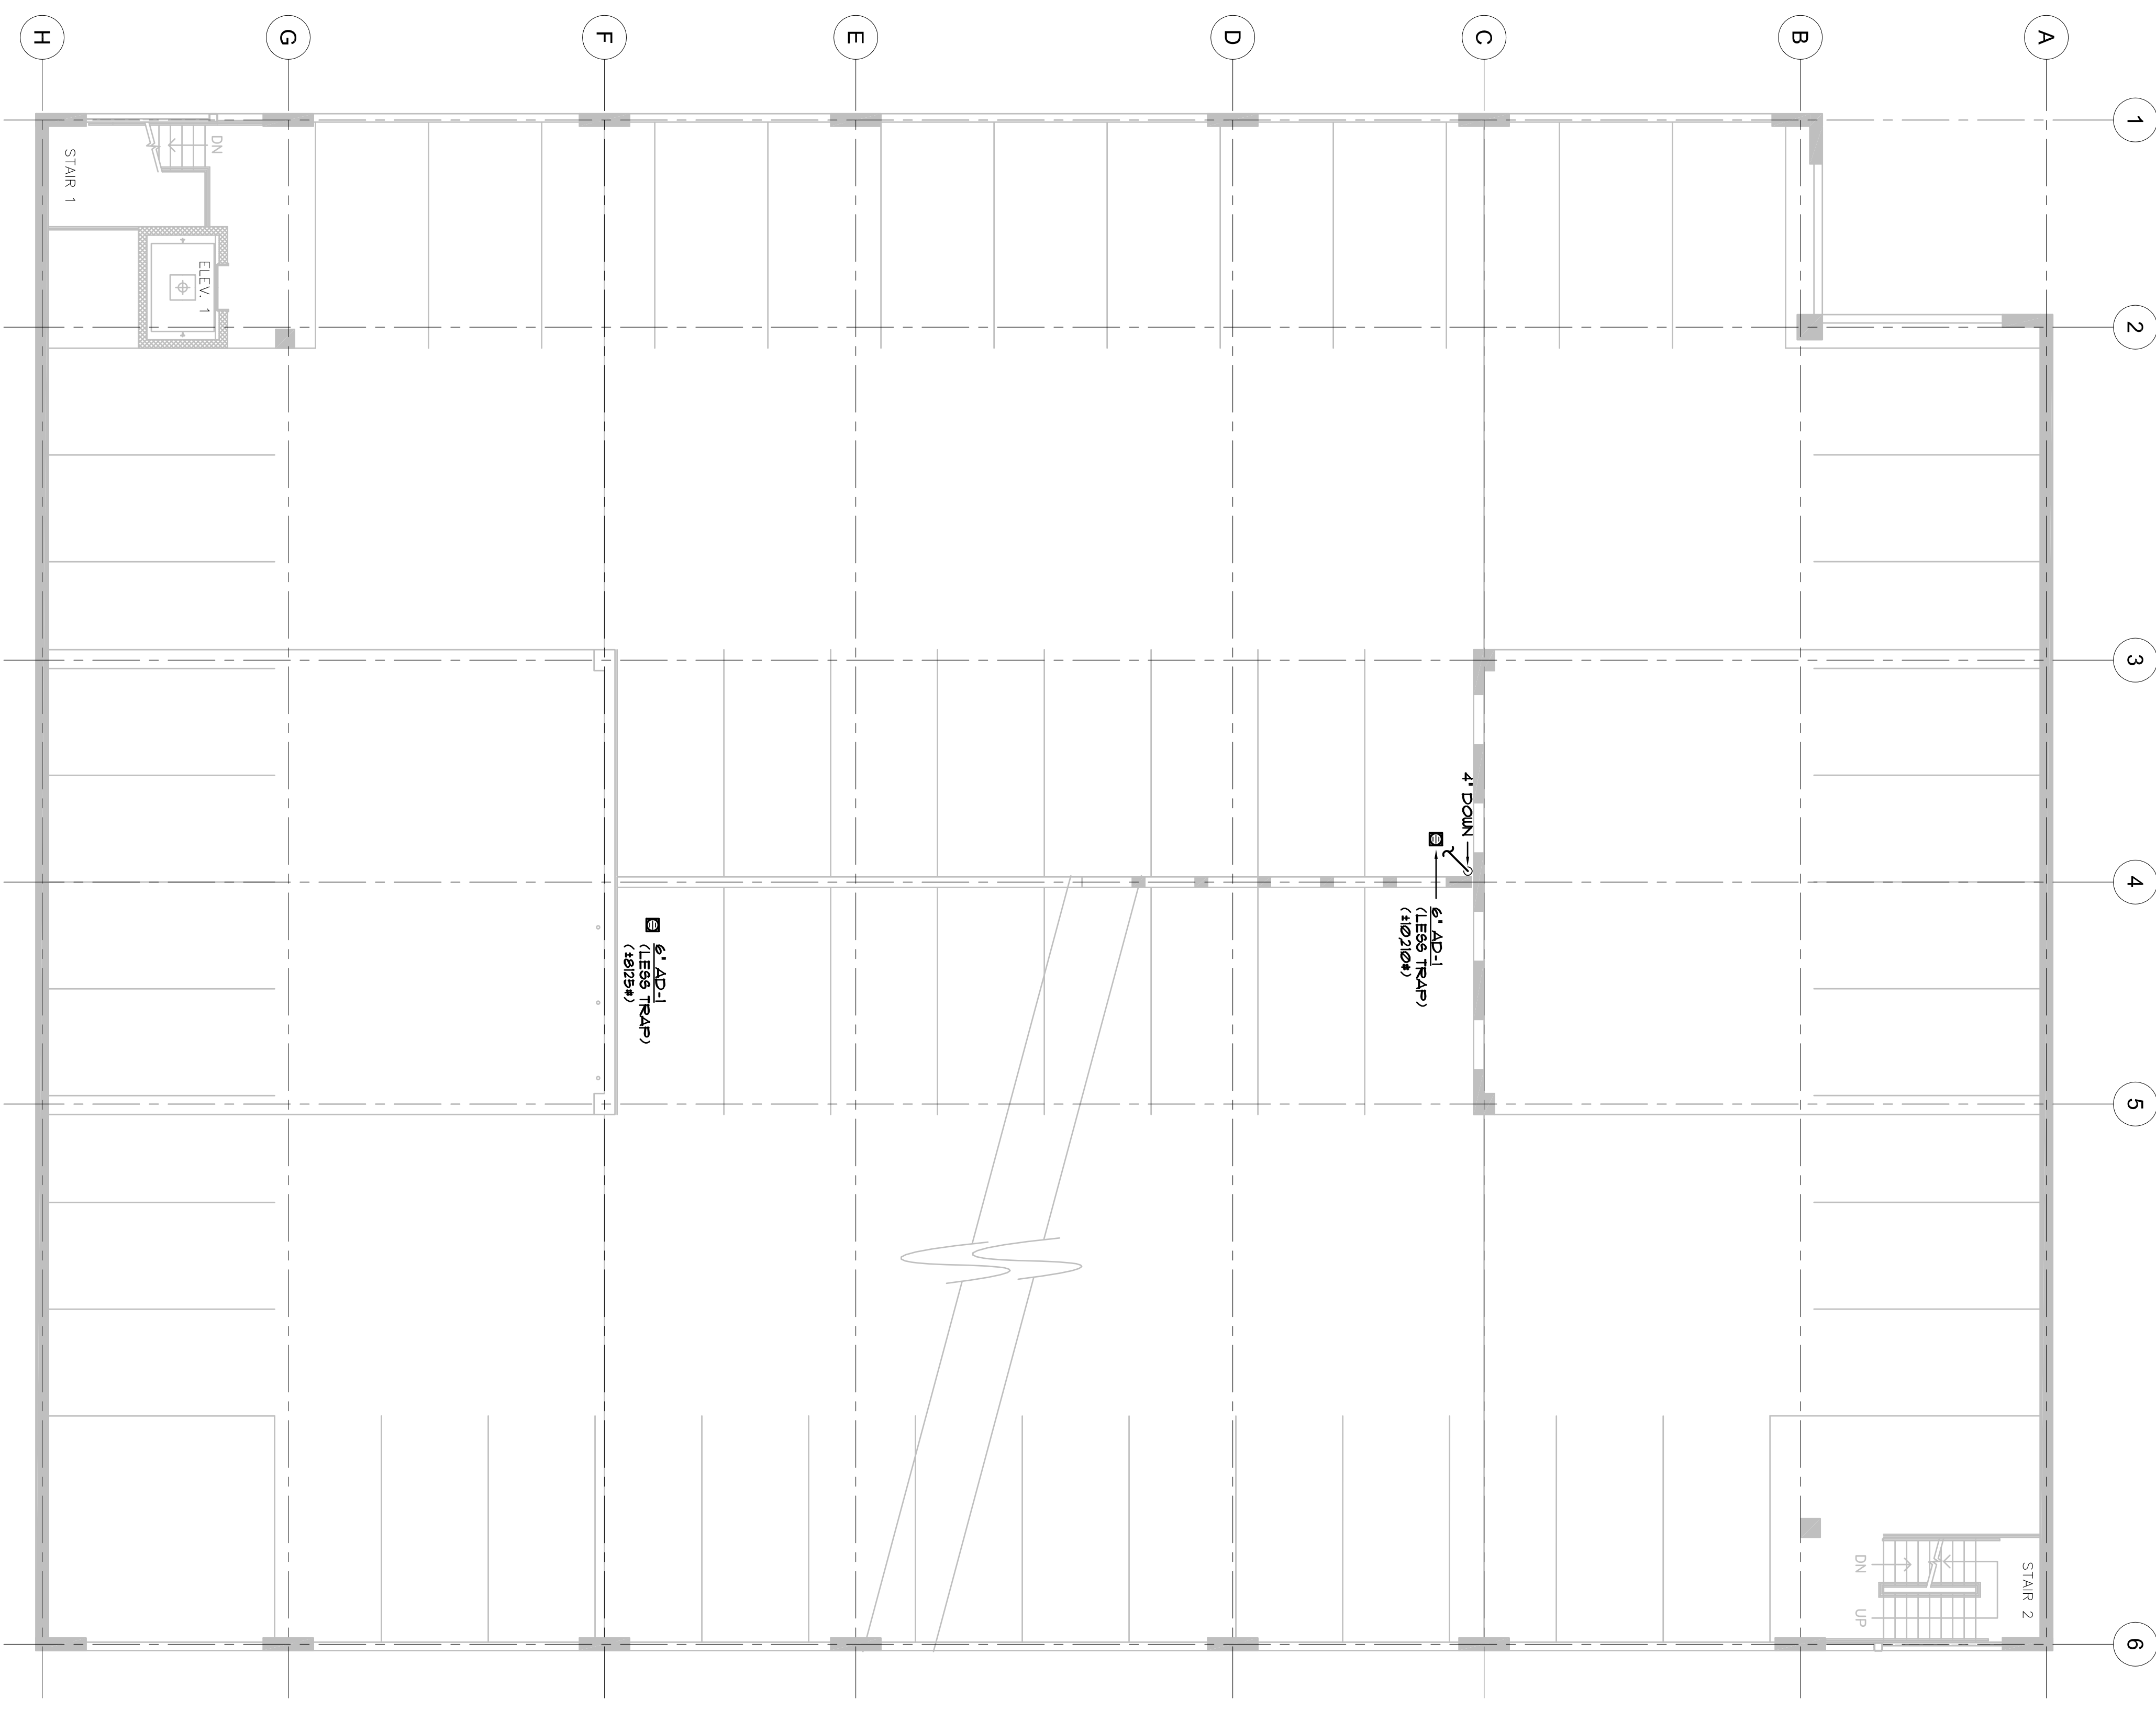

PARKING LEVEL THREE PLUMBING PLAN
SCALE: 1/8" = 1'-0"
NORTH

PROJ. NO. 15088.00
DRAWN: TLF
CHECKED: DER
CADD FILE: GG-M4.3.DWG
DATE: 06.16.08
REVISIONS:
ADD. NO. 1 07.26.08
ADD. NO. 2 8.10.08
ADD. NO. 2 9.27.08

RECORD DRAWING: 01.14.08
©OZ ARCHITECTURE

GURA GARAGE
ISSUED FOR
CONSTRUCTION - 9/29/06
SHEET TITLE:
PARKING
LEVEL THREE
PLUMBING PLAN
SCALE: AS NOTED
SHEET NUMBER:
M4.3

THE CONTRACTOR, INCLUDING ALL IDEAS AND DESIGN, IS RESPONSIBLE FOR THE MECHANICAL SYSTEMS, INCLUDING THE DESIGN, INSTALLATION, TESTING, AND MAINTENANCE OF THE SYSTEMS. THE CONTRACTOR SHALL BE RESPONSIBLE FOR OBTAINING ALL NECESSARY PERMITS AND APPROVALS FROM THE LOCAL AUTHORITIES. THE CONTRACTOR SHALL BE RESPONSIBLE FOR THE PROTECTION OF ALL EXISTING UTILITIES AND STRUCTURES. THE CONTRACTOR SHALL BE RESPONSIBLE FOR THE PROTECTION OF ALL EXISTING MECHANICAL SYSTEMS. THE CONTRACTOR SHALL BE RESPONSIBLE FOR THE PROTECTION OF ALL EXISTING MECHANICAL SYSTEMS.