




1820 Polkorn Street
Boulder, Colorado 80302
phone 303.449.8900



INMS
INNOVATIVE
MECHANICAL
SYSTEMS, INC.
1300 CHESTNUT STREET, SUITE A
BOULDER, CO 80501-3002
PHONE 303.440.0800
FAX 303.440.1100

GOLDEN GURA GARAGE

1250 Jackson St.
Golden, Colorado

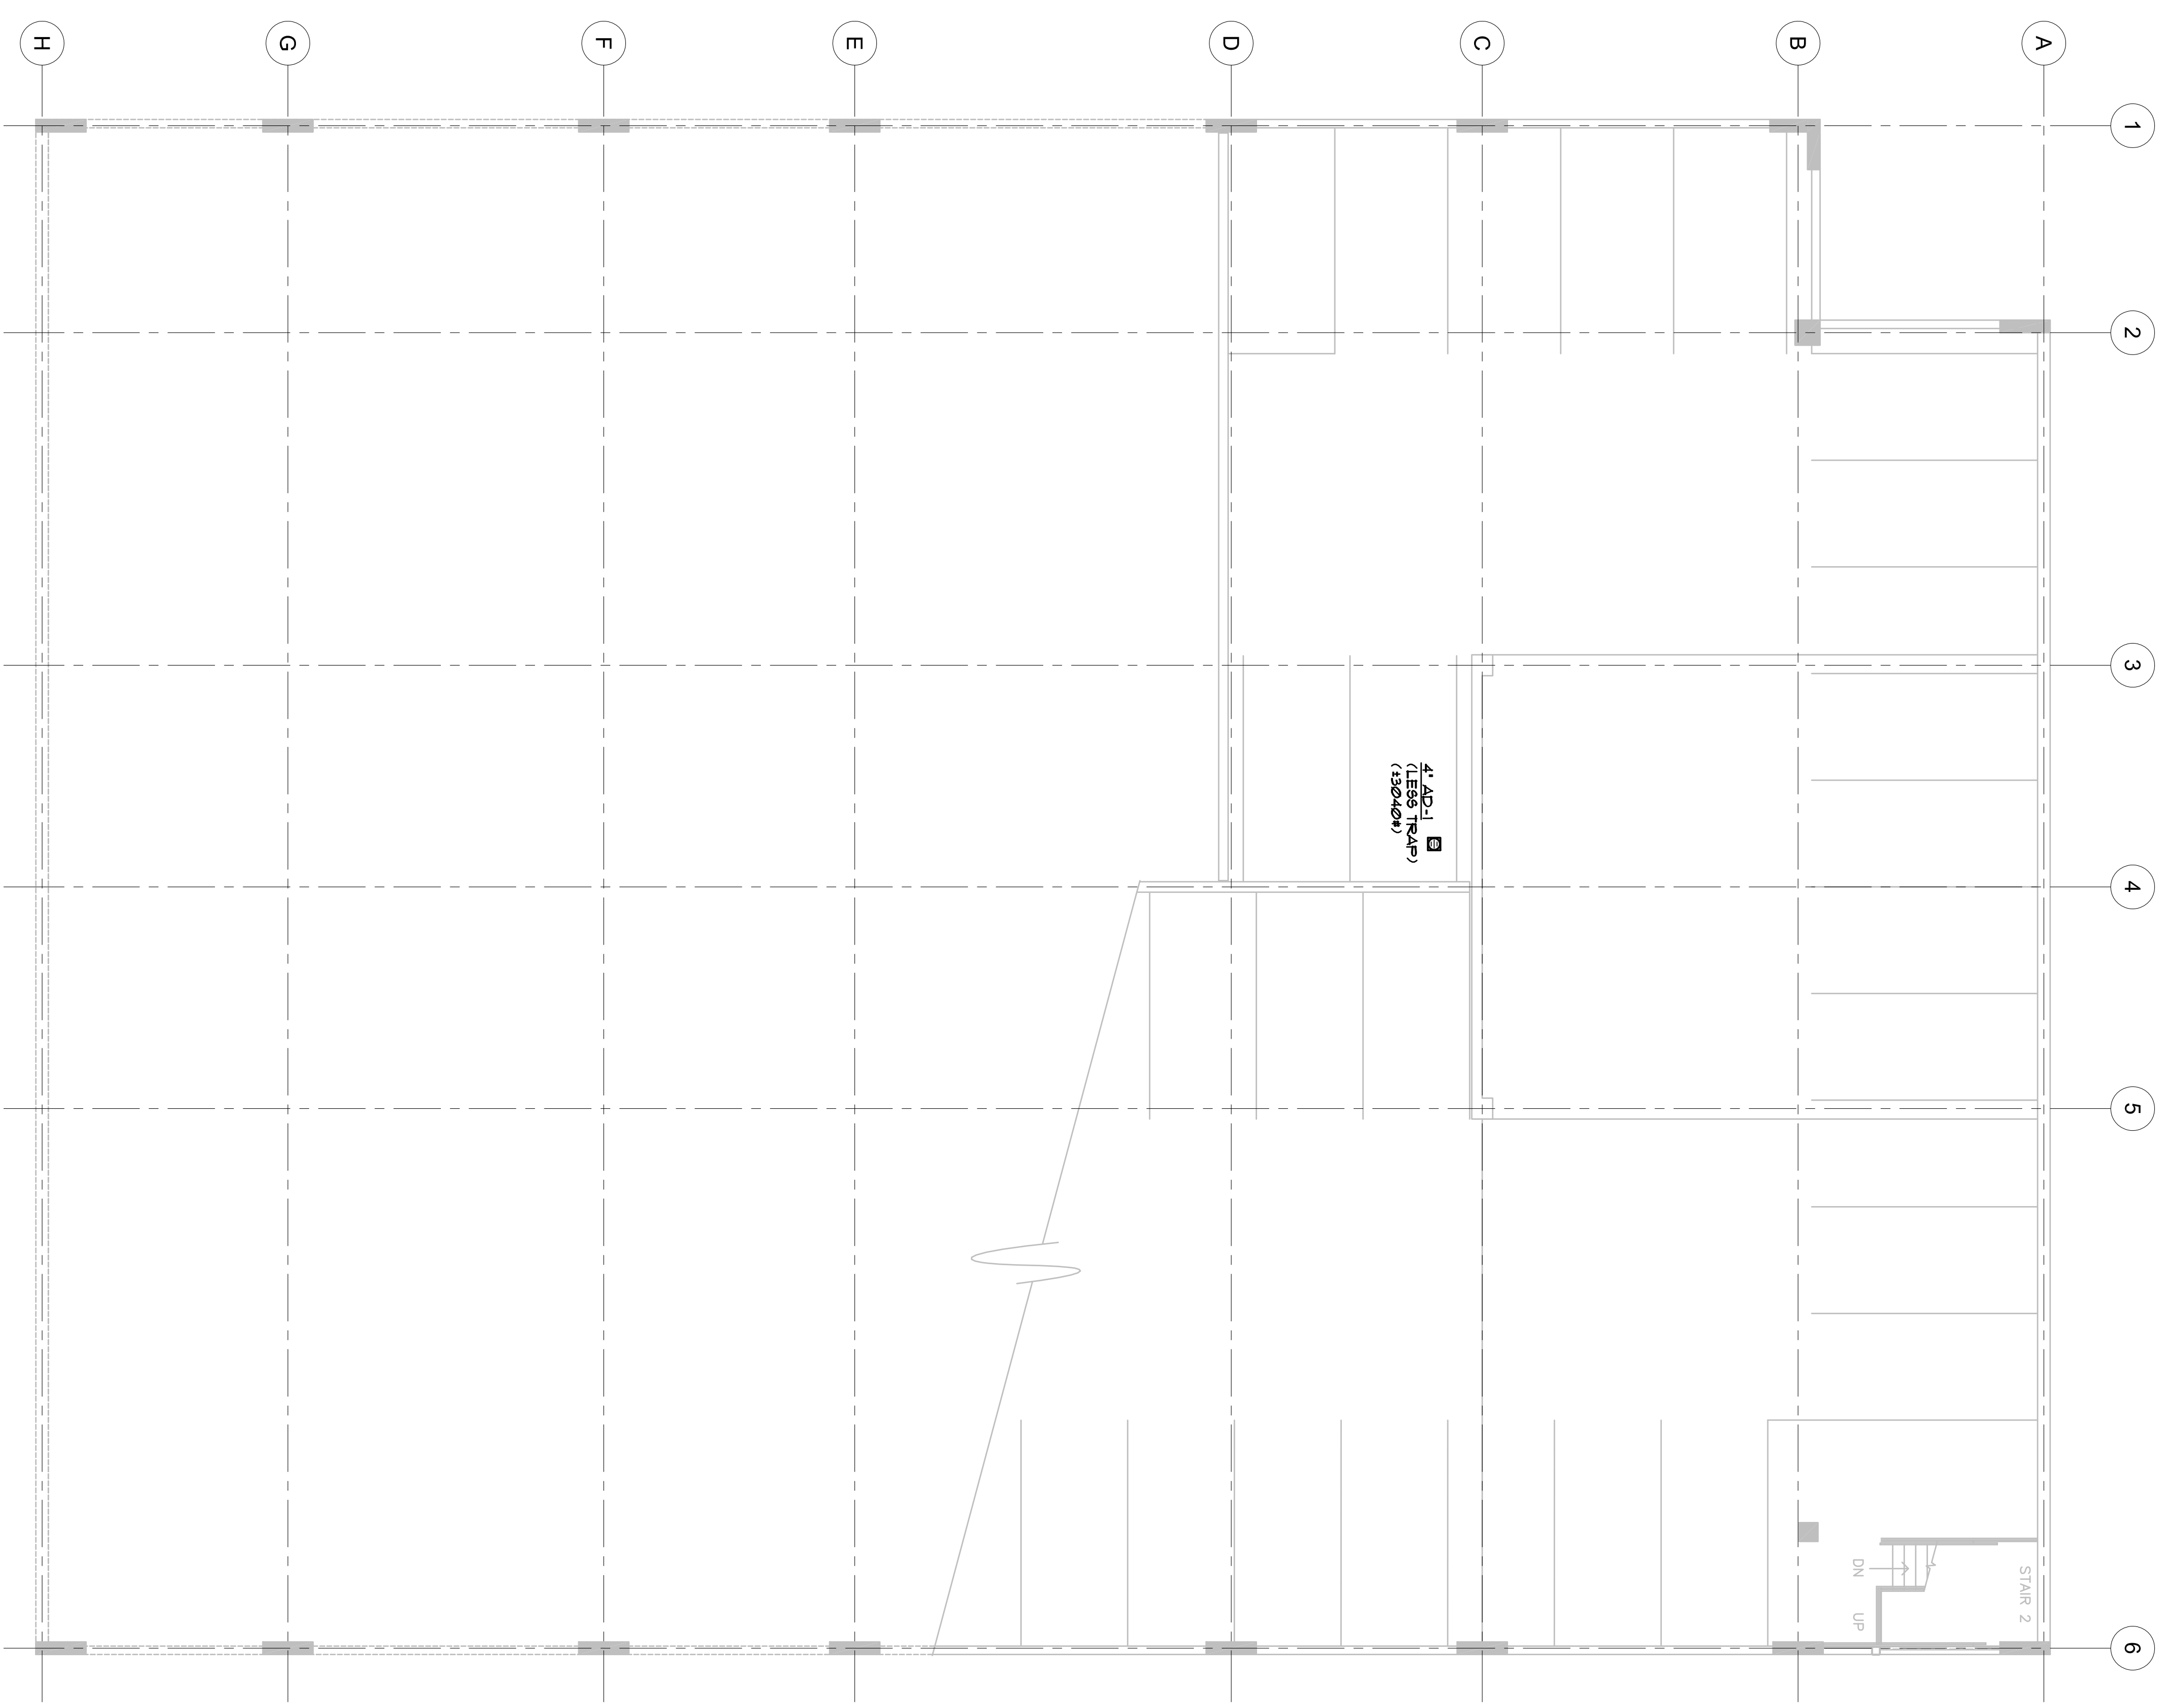

PARKING LEVEL FOUR PLUMBING PLAN
SCALE: 1/8" = 1'-0"
NORTH

PROJ. NO. 15038.00
DRAWN: TLF
CHECKED: DER
CADD FILE: GG-H4-4.DWG
DATE: 06.16.06
REVISIONS:
▲ ADD. NO. 1 07.26.06 8.10.06
▲ ADD. NO. 2 9.27.06
RECORD DRAWING: 01.14.08
©OZ ARCHITECTURE

GURA GARAGE
ISSUED FOR
CONSTRUCTION - 9/29/06
SHEET TITLE:
PARKING
LEVEL FOUR
PLUMBING PLAN
SCALE: AS NOTED
SHEET NUMBER:

M4.4

THE CONTRACTOR SHALL BE RESPONSIBLE FOR OBTAINING ALL NECESSARY PERMITS AND APPROVALS FROM THE LOCAL, STATE AND FEDERAL AGENCIES. THE CONTRACTOR SHALL BE RESPONSIBLE FOR OBTAINING ALL NECESSARY PERMITS AND APPROVALS FROM THE LOCAL, STATE AND FEDERAL AGENCIES. THE CONTRACTOR SHALL BE RESPONSIBLE FOR OBTAINING ALL NECESSARY PERMITS AND APPROVALS FROM THE LOCAL, STATE AND FEDERAL AGENCIES.