




1820 Polkorn Street
Boulder, Colorado 80302
phone 303.449.8900



INMS
INNOVATIVE
MECHANICAL
SYSTEMS, INC.
1580 CHESTNUT STREET, SUITE A
BOULDER, CO 80501-3088
PHONE 303.440.0888
FAX 303.440.1188

GOLDEN GURA GARAGE

1250 Jackson St.
Golden, Colorado

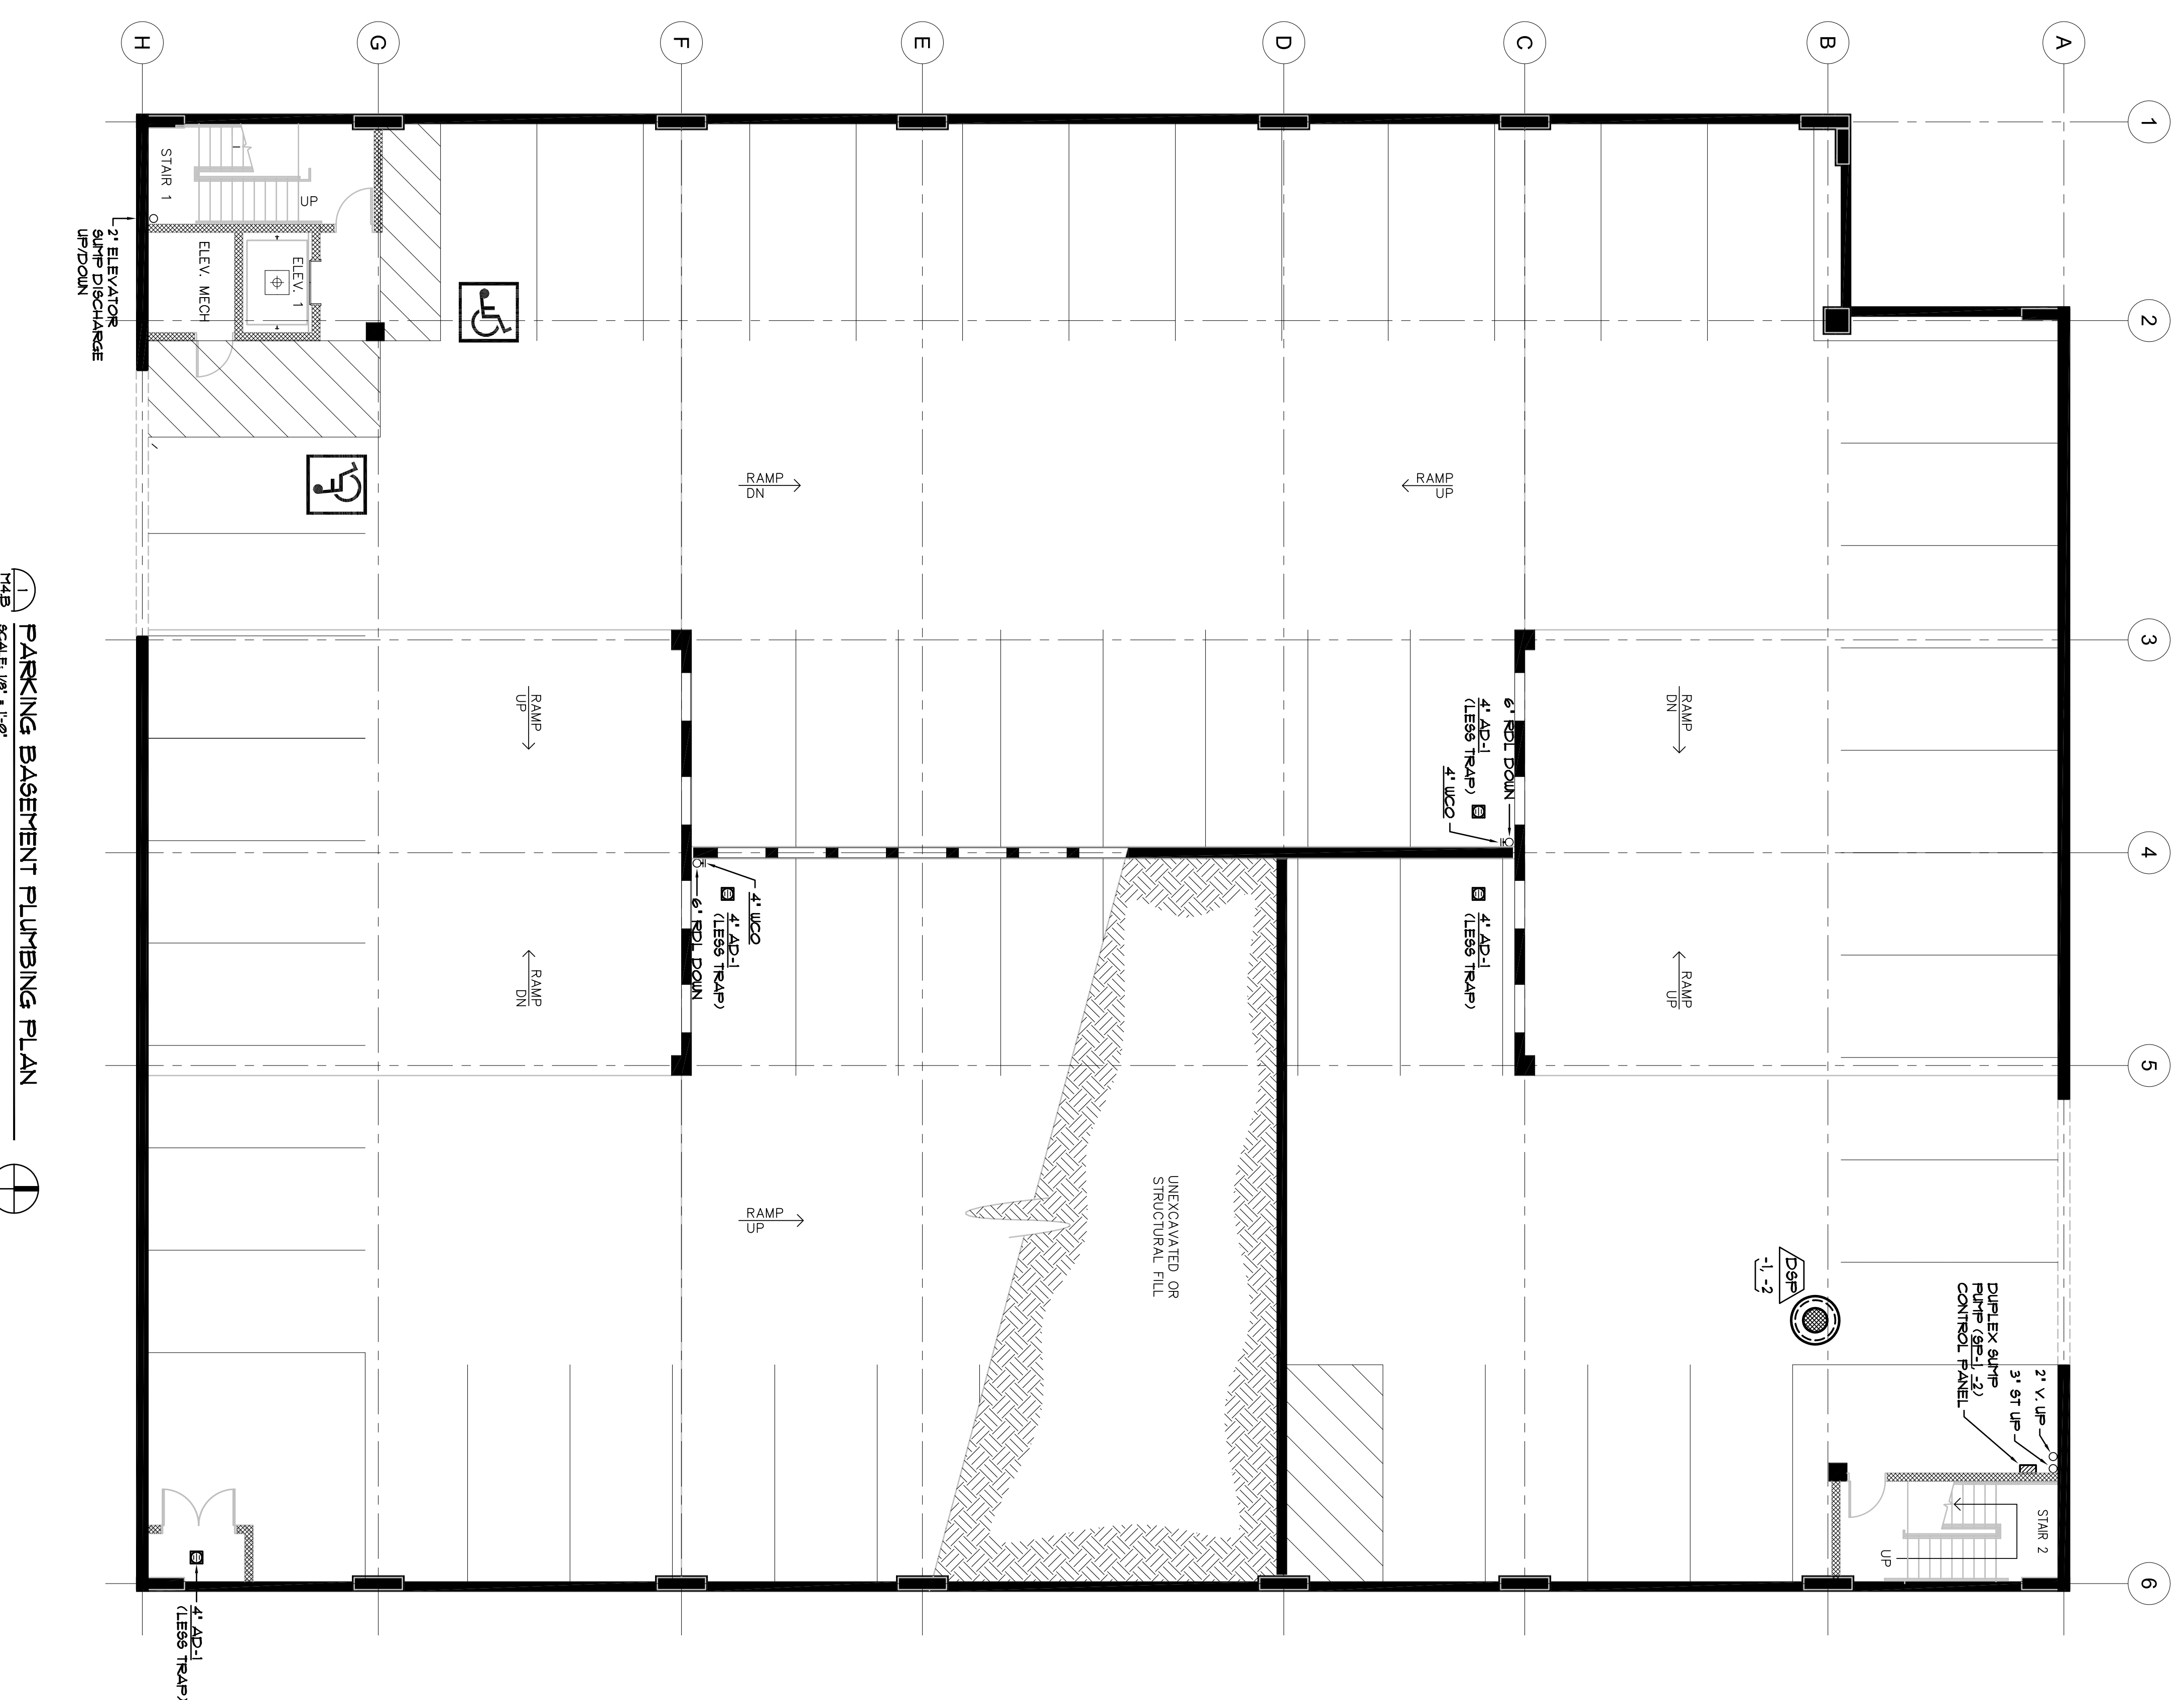

PARKING BASEMENT PLUMBING PLAN
SCALE: 1/8" = 1'-0"
NORTH

PROJ. NO. 15938.00
DRAWN: TLF
CHECKED: DER
CADD FILE: GC-M4.B.DWG
DATE: 06.16.06
REVISIONS:
ADD. NO. 1 07.26.06
ADD. NO. 2 8.10.06
ADD. NO. 2 9.27.06

RECORD DRAWINGS: 01:14:08
©OZ ARCHITECTURE

GURA GARAGE
ISSUED FOR
CONSTRUCTION - 9/29/06

SHEET TITLE:
PARKING
BASEMENT
PLUMBING PLAN
SCALE: AS NOTED
SHEET NUMBER:
M4.B

THE CONTRACTOR, INCLUDING ALL IDEAS AND DESIGN, IS RESPONSIBLE FOR THE MECHANICAL SYSTEMS, INCLUDING THE DESIGN, INSTALLATION, TESTING, AND MAINTENANCE OF THE SYSTEMS. THE CONTRACTOR SHALL BE RESPONSIBLE FOR THE DESIGN AND CONSTRUCTION OF THE SYSTEMS. THE CONTRACTOR SHALL BE RESPONSIBLE FOR THE DESIGN AND CONSTRUCTION OF THE SYSTEMS. THE CONTRACTOR SHALL BE RESPONSIBLE FOR THE DESIGN AND CONSTRUCTION OF THE SYSTEMS.